

ASSOCIATED DESIGN GROUP, INC.
A PROFESSIONAL ENGINEERING COMPANY

adginc@adginc.org

CORPORATE OFFICE

114 Toledo Drive
Metairie, Louisiana 70006
VOICE (337) 237-4570
FAX (337) 237-1467

NEW ORLEANS BRANCH
1010 Commons Suite 2405
New Orleans, LA 70112
(504) 561-6333

This drawing, as an instrument of service, is owned and shall remain the property of Associated Design Group, Inc. It is to be used only for the project and site specifically identified herein, and shall not be reproduced, published or used in any way, except for this specific project, (A05 Project) without the written consent and permission of Associated Design Group, Inc.

Warning: Unlicensed reproduction of this document may violate U.S. Copyright Law and may be subject to legal prosecution.


© Associated Design Group, Incorporated 2008

FIRE ALARM REPLACEMENT PROJECT


Revisions

No.	By	REVISIONS/SUBMISSIONS	Date
1			
2			
3			

ERNEST N.
MORAL
CONVENTION
CENTER
NEW ORLEANS, LOUISIANA

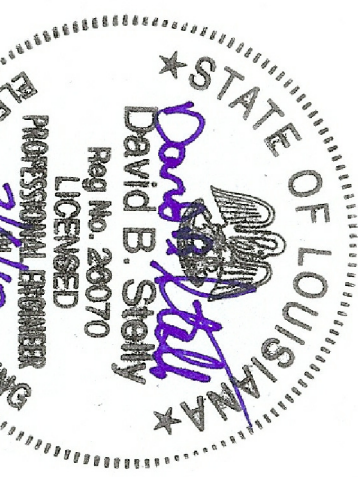

A05 project number: 09258
drawing number: FA2.2B
drawn by: DJH
checked by: GPM
quality control by:
JUN-06-2010 page 10.3 of 127

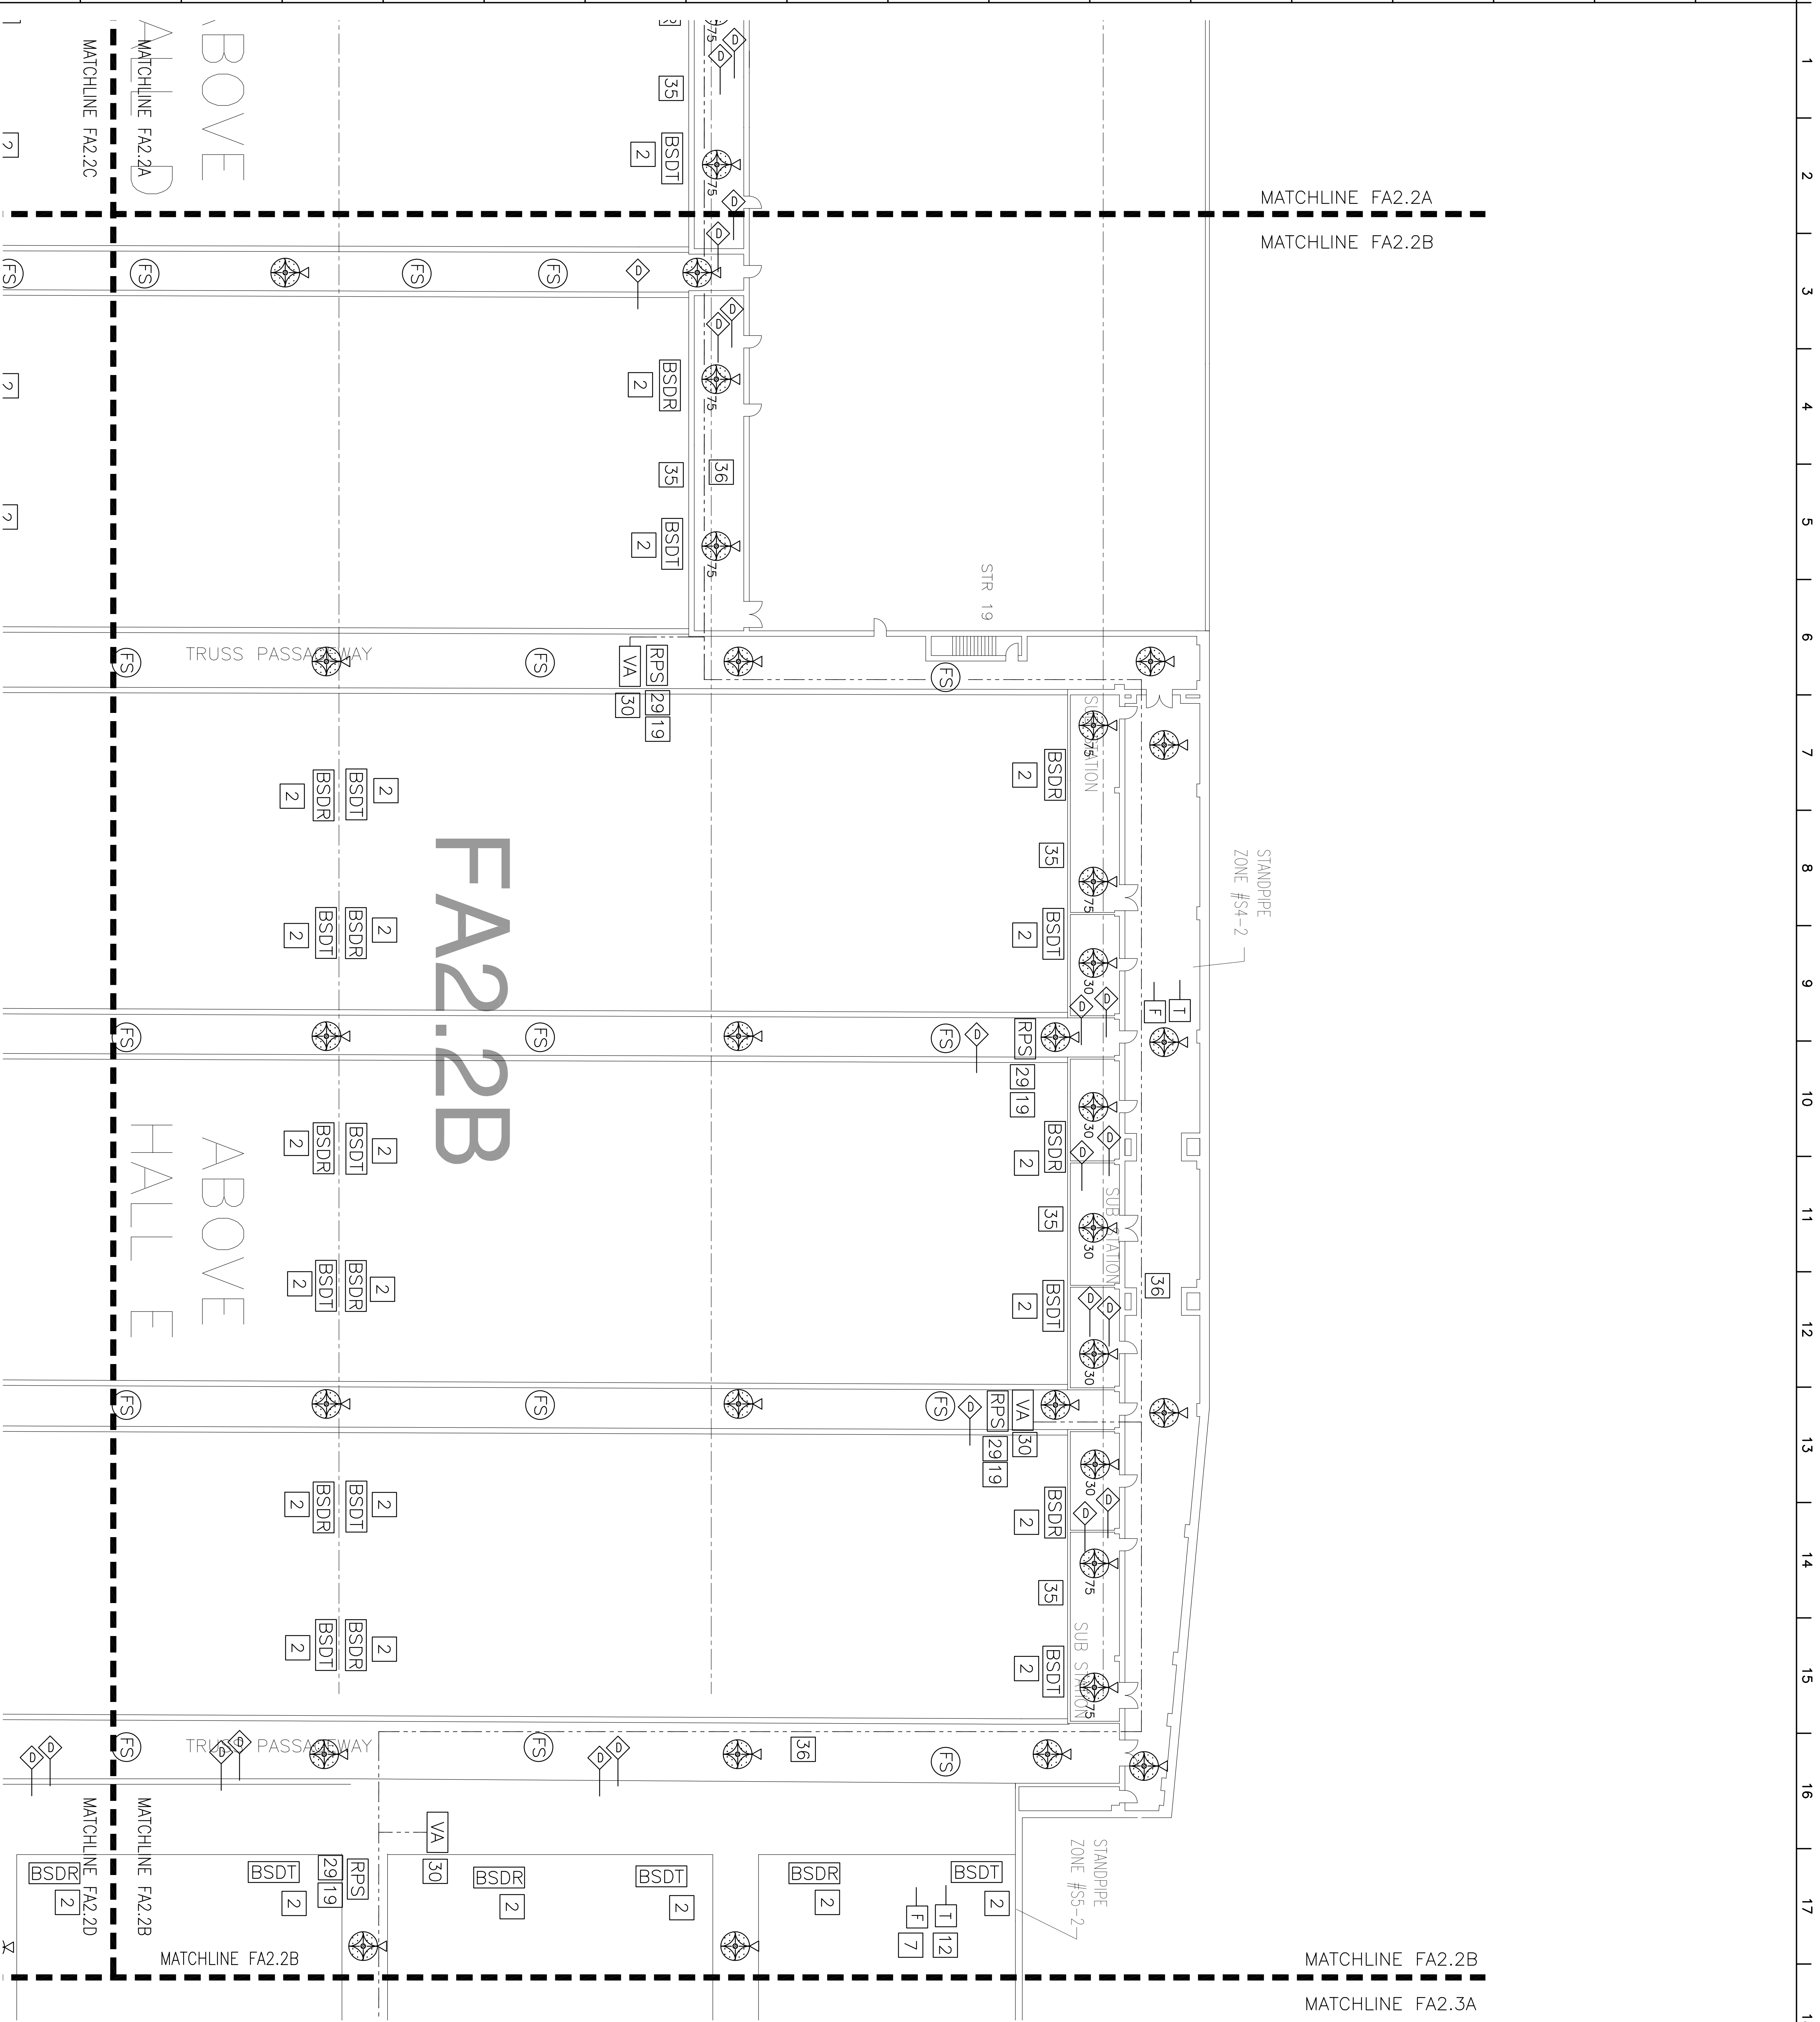

1 LEVEL 2 FIRE ALARM PLAN - QUAD FA2.2B
SCALE: 1/16"=1'-0"

REFER TO SHEET FA2.1
FOR NOTES AND LEGEND