

ASSOCIATED DESIGN GROUP, INC.
A PROFESSIONAL ENGINEERING COMPANY
adginc@adginc.org

CORPORATE OFFICE
114 Tokelo Drive
Lafayette, Louisiana 70506
VOICE (337) 237-4570
FAX (337) 237-1467

NEW ORLEANS BRANCH
1010 Commons Suite 2405
New Orleans, LA 70112
(504) 561-6333

This drawing, as an instrument of service, is and shall remain the property of Associated Design Group, Inc. It is not to be reproduced, published or used in any way except for this specific project. (A05 Project) written consent and permission of Associated Design Group, Inc.

Warning: Unlicensed reproduction of this document may violate U.S. Copyright Law and may be subject to legal prosecution.
© Associated Design Group, Incorporated 2008


FIRE ALARM REPLACEMENT PROJECT

Revisions		
No.	By	Date
1		
2		
3		

ERNEST N. MORAL
CONVENTION CENTER
NEW ORLEANS, LOUISIANA



A05 project number: 09258
drawing number: FA2.4B
drawn by: DJH
checked by: GPM
quality control by:
JULY-06-2010
page 111 of 127

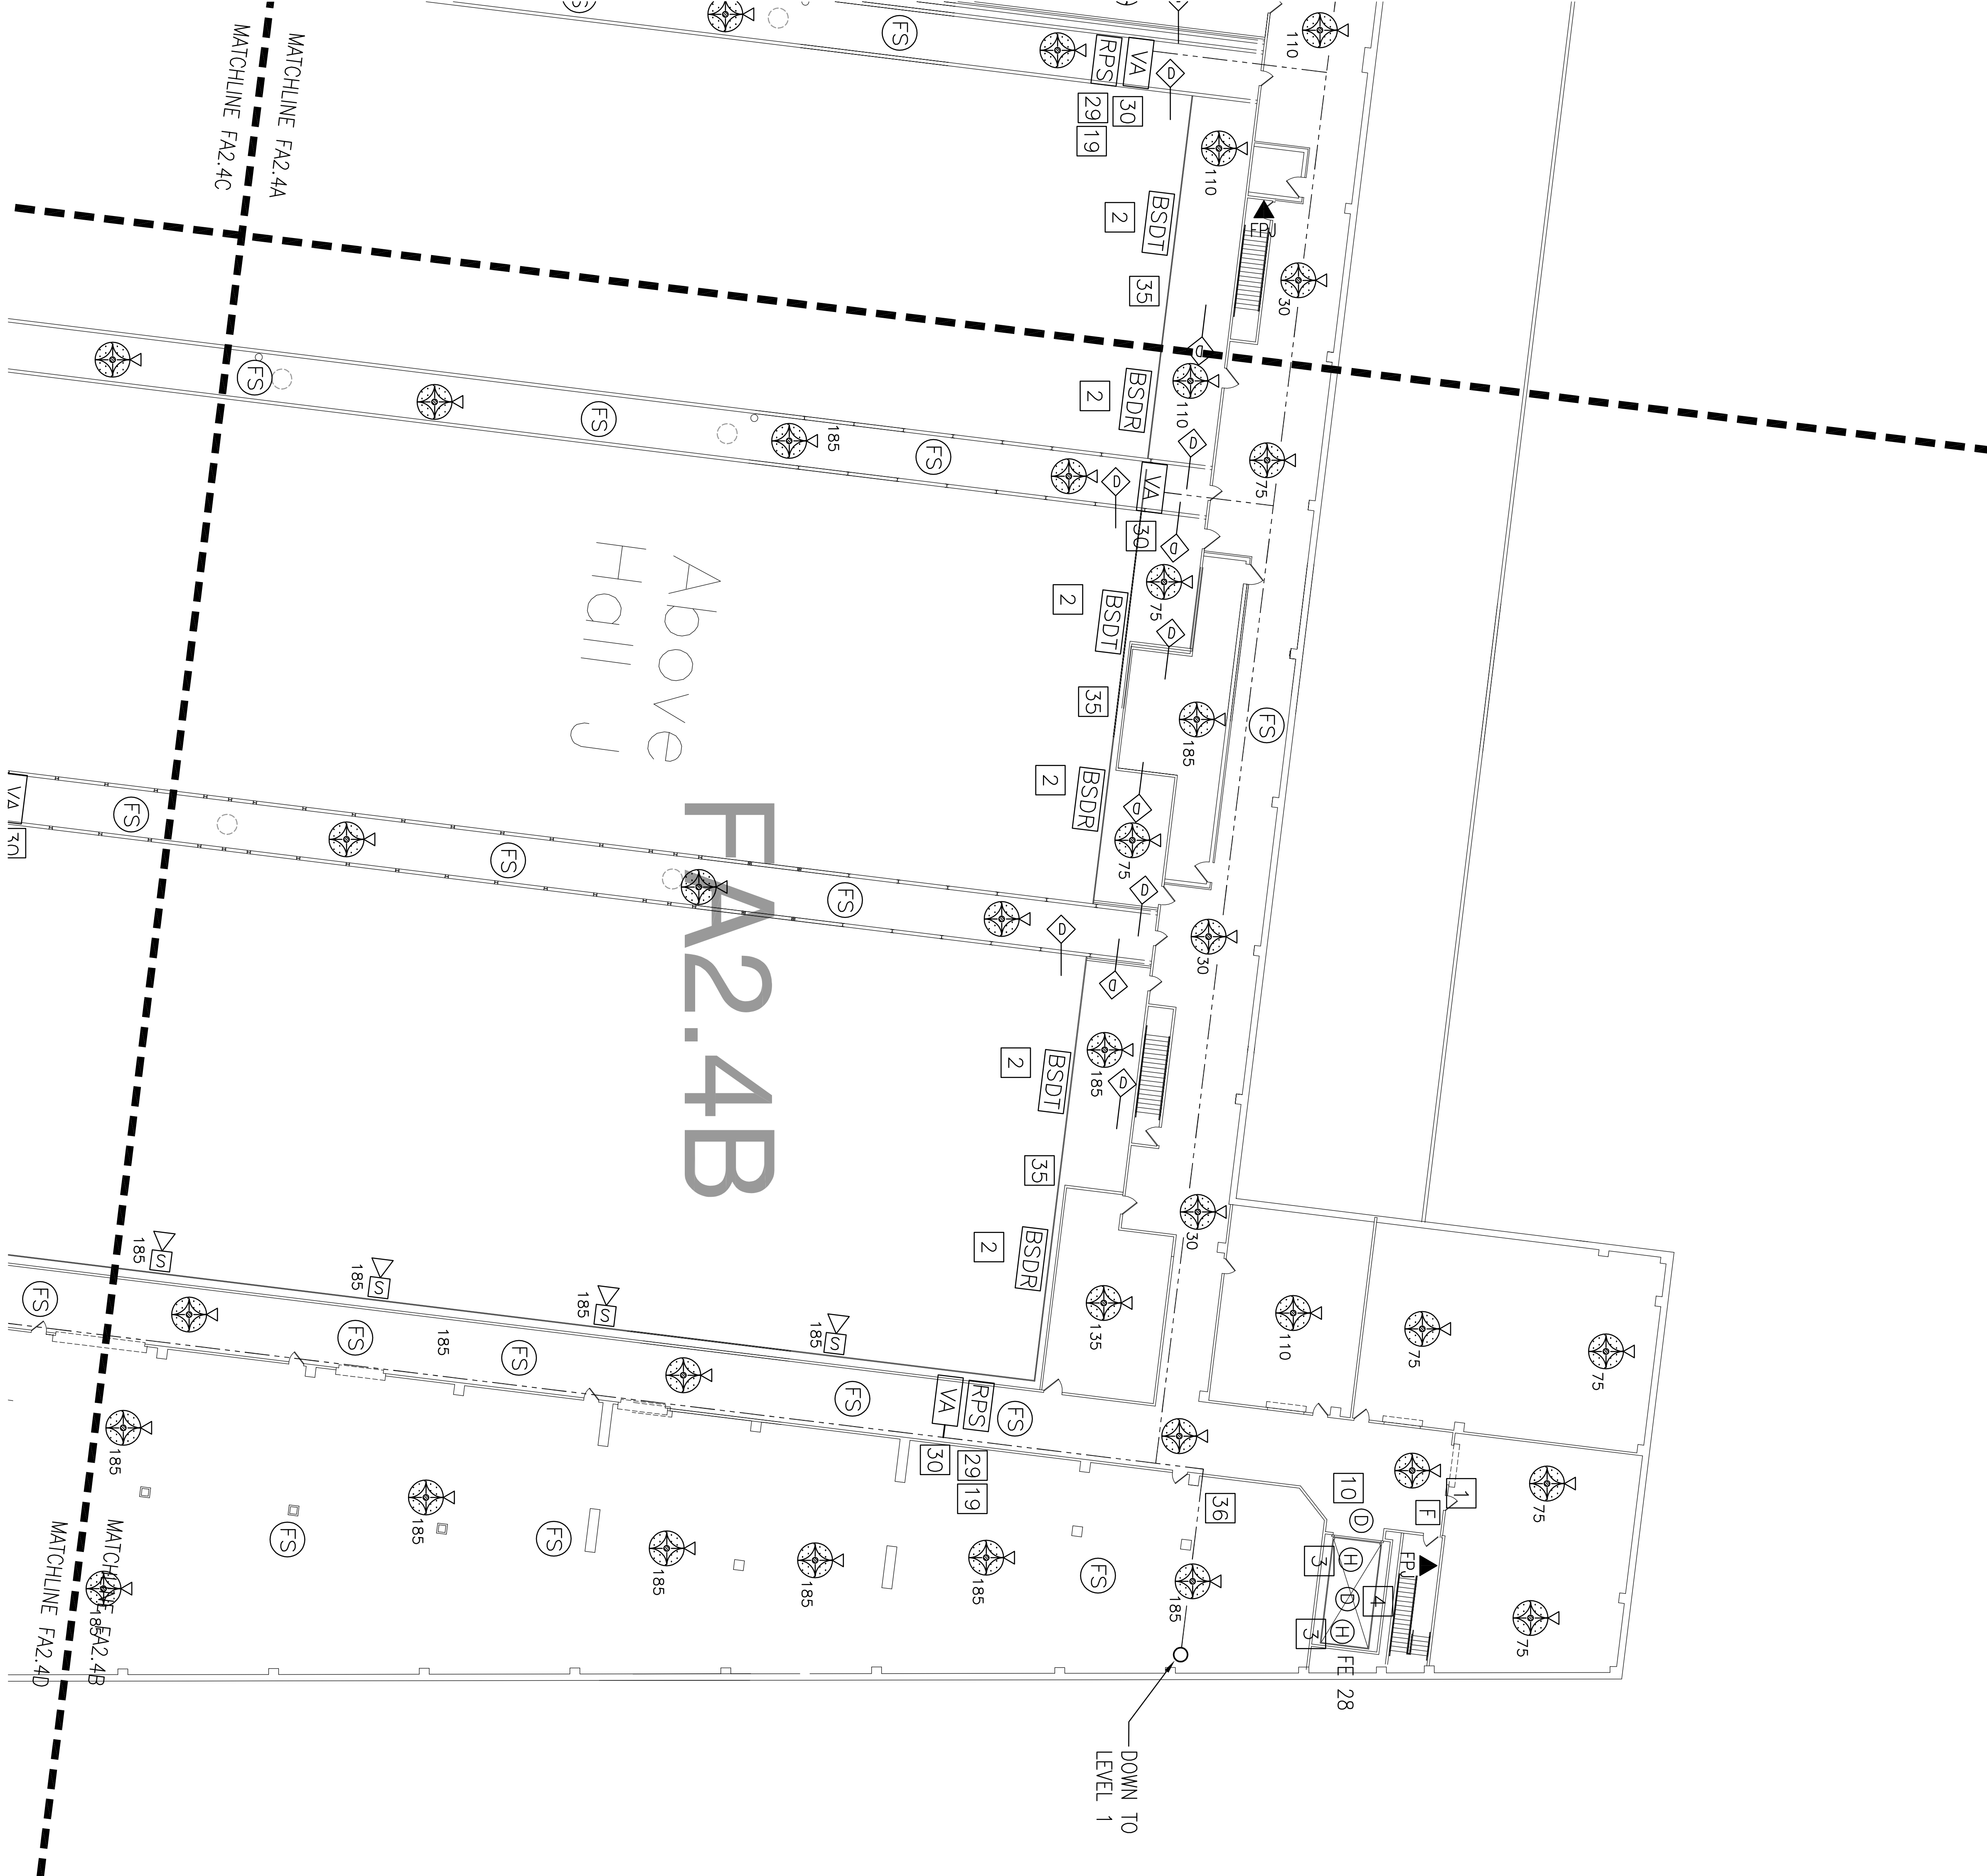

FA2.4B

Above Hall J

1 LEVEL 2 FIRE ALARM PLAN - QUAD FA2.4B
SCALE: 1/16"=1'-0"

REFER TO SHEET FA5.1 FOR NOTES AND LEGEND